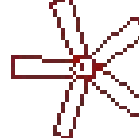
 


ELECTRICAL - DATA - AUDIO LEGEND	
SYMBOL	DESCRIPTION
	Ceiling Fan
	Ventilation Fans: Ceiling Mounted, Wall Mounted
	Ceiling Mounted Light Fixtures: Surface/Pendant, Recessed, Heat Lamp, Low Voltage
	Wall Mounted Light Fixtures: Flush Mounted, Wall Sconce
	Chandelier Light Fixture
	Fluorescent Light Fixture
	240V Receptacle
	110V Receptacles: Duplex, Weather Proof, GFCI
	Switches: Single Pole, Weather Proof, 3-Way, 4-Way
	Switches: Dimmer, Timer
	Audio Video: Control Panel, Switch
	Speakers: Ceiling Mounted, Wall Mounted
	Wall Jacks: CAT5, CAT5 + TV, TV/Cable
	Telephone Jack
	Intercom
	Thermostat
	Door Chime, Door Bell Button
	Smoke Detectors: Ceiling Mounted, Wall Mounted
	Electrical Breaker Panel
	Cook Top Receptacle

ELECTRICAL SCHEDULE	
1	@ 52" F/F.F.L.
2	@40 F/F.F.L.
3	@25 F/F.F.L.
4	@25" F/F.F.L.
5	@11.5" F/F.F.L.
6	@57" F/F.F.L.
7	@11.5 F/F.F.L.
8	@43" F/F.F.L.
9	@22.5" F/F.F.L.
10	@11.5" F/F.F.L.
11	@11.5" F/F.F.L. (AC)


ELECTRICAL NOTES:

ALL NEW ELECTRICAL FEATURES MUST BE SURFACE MOUNTED


INSTALL ALL BHC SUPPLIED LIGHTS AND CEILING FANS

INSTALL AC OUTLETS PER SPECIFICATIONS

REPEAT, FLIP AND MIRROR FOR BEDROOMS

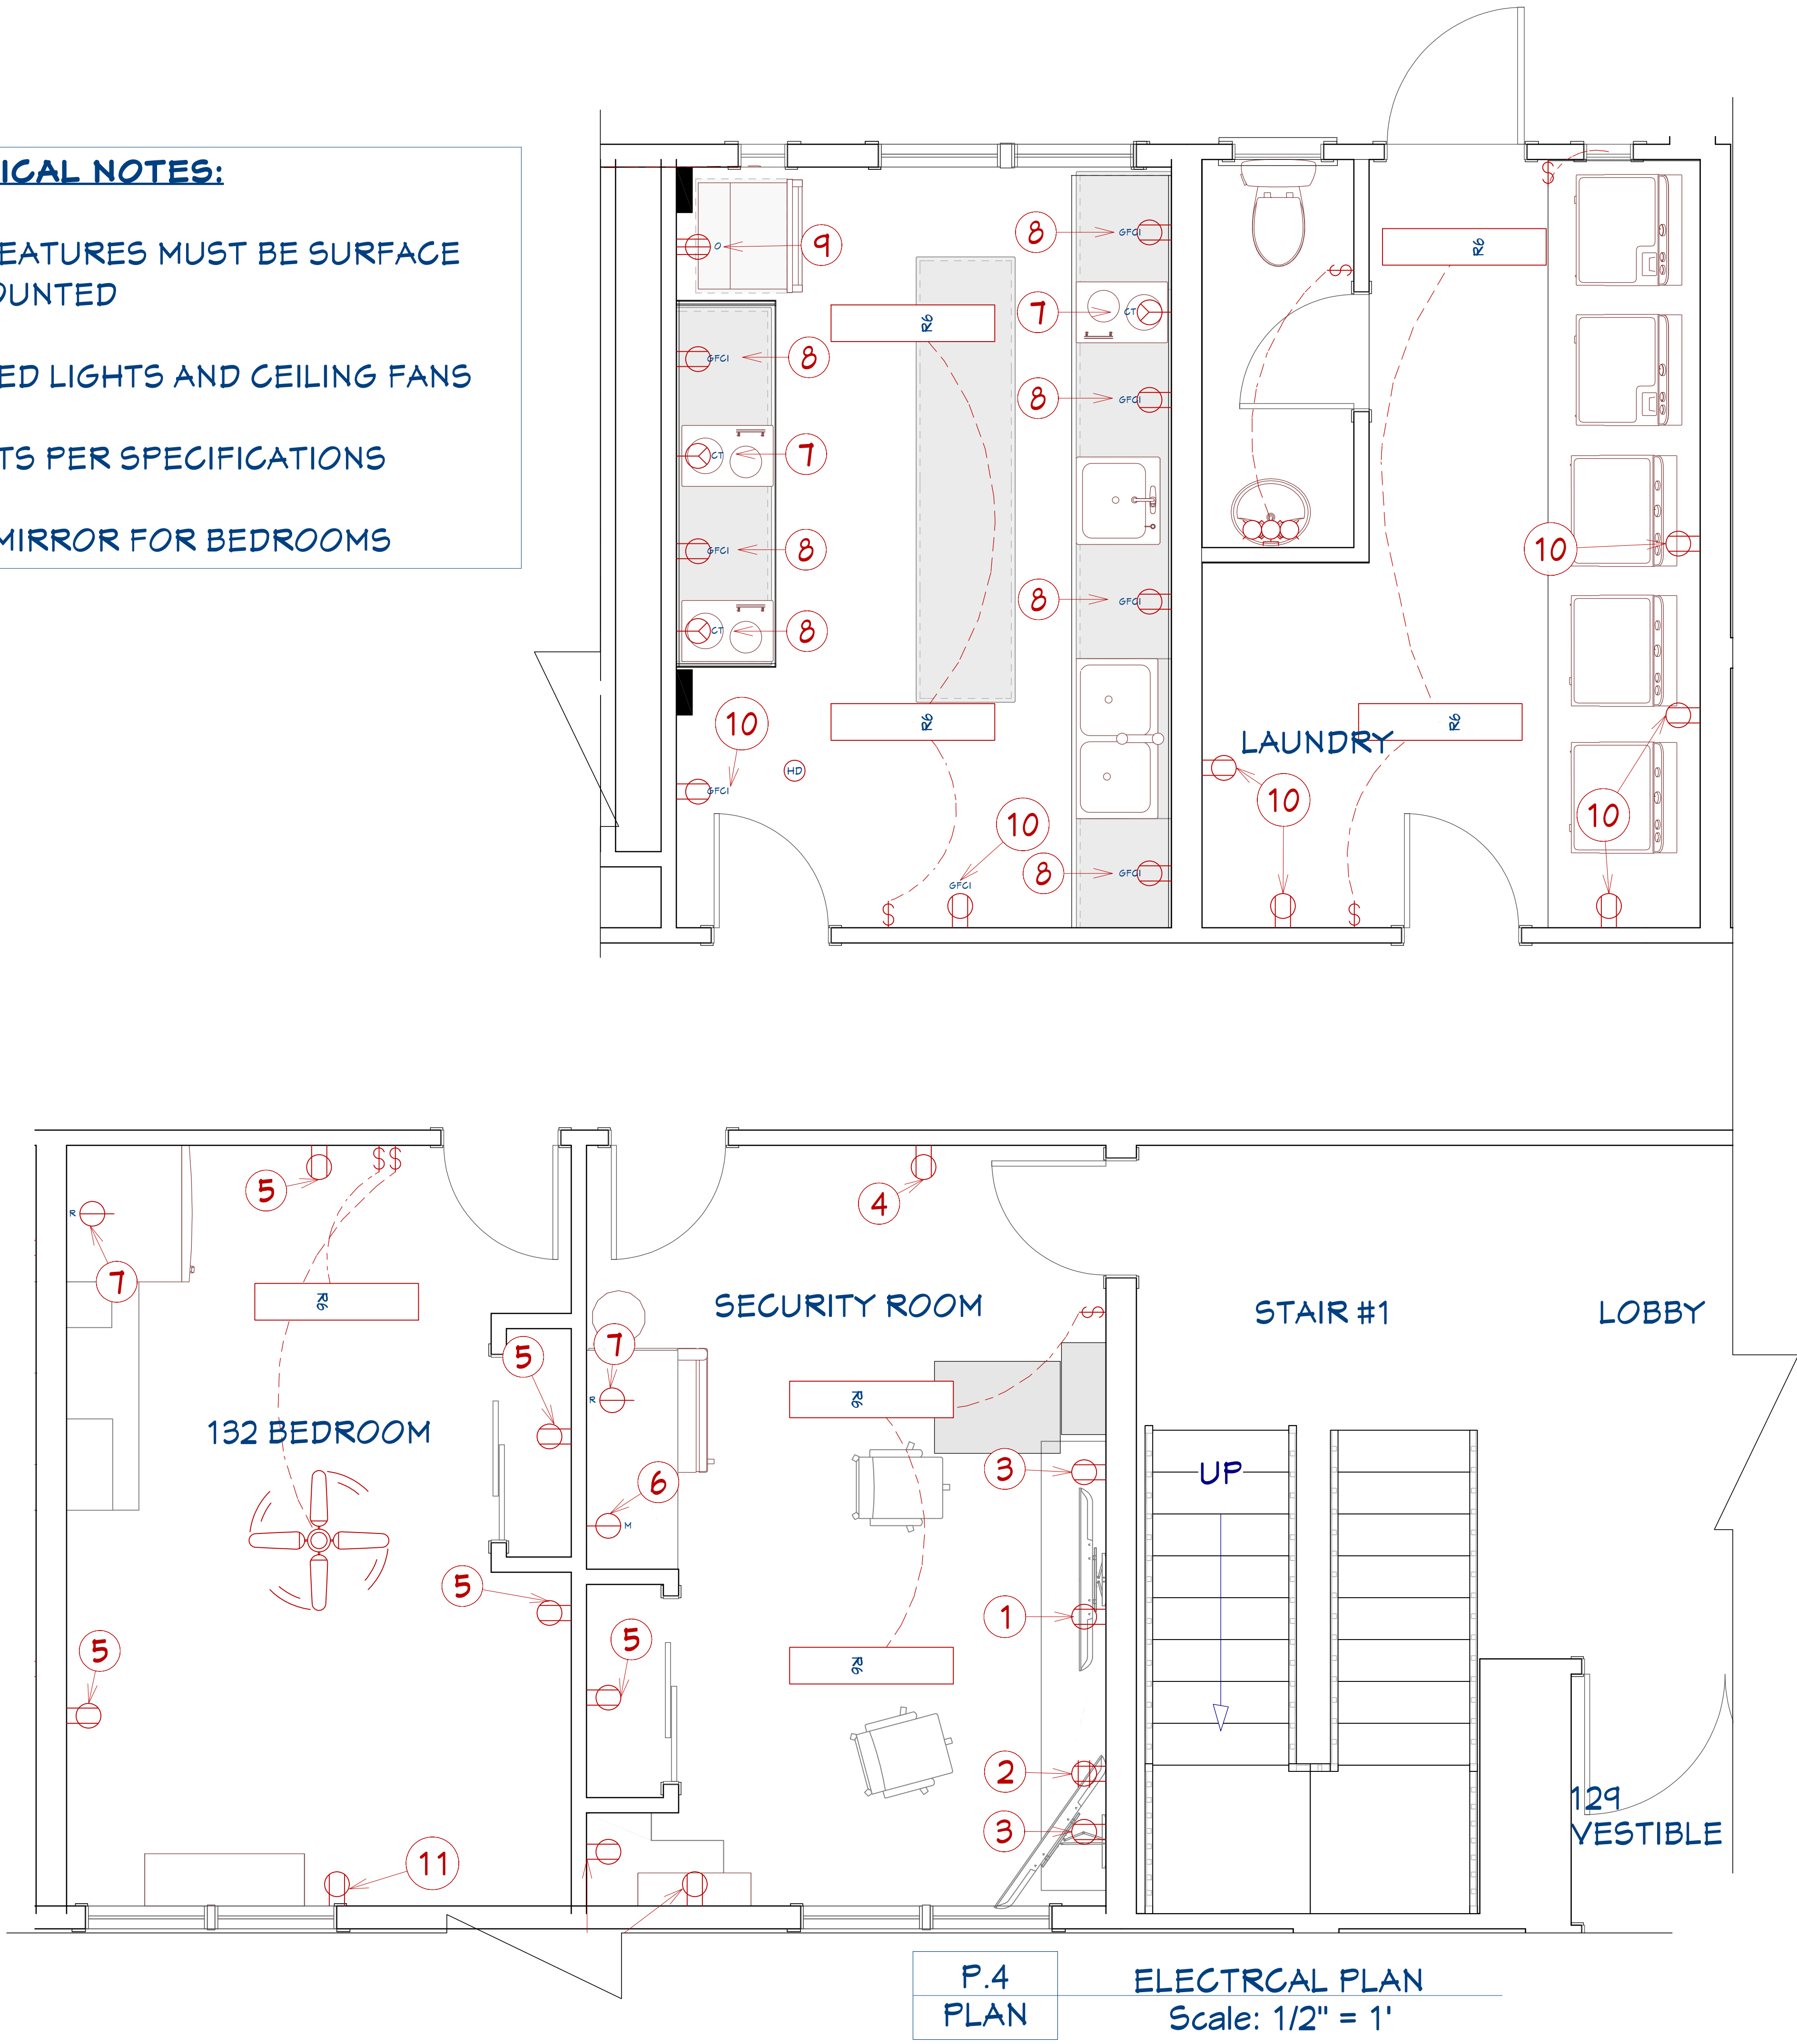

REVISION TABLE	REVISION BY	DESCRIPTION
NUMBER	DATE	

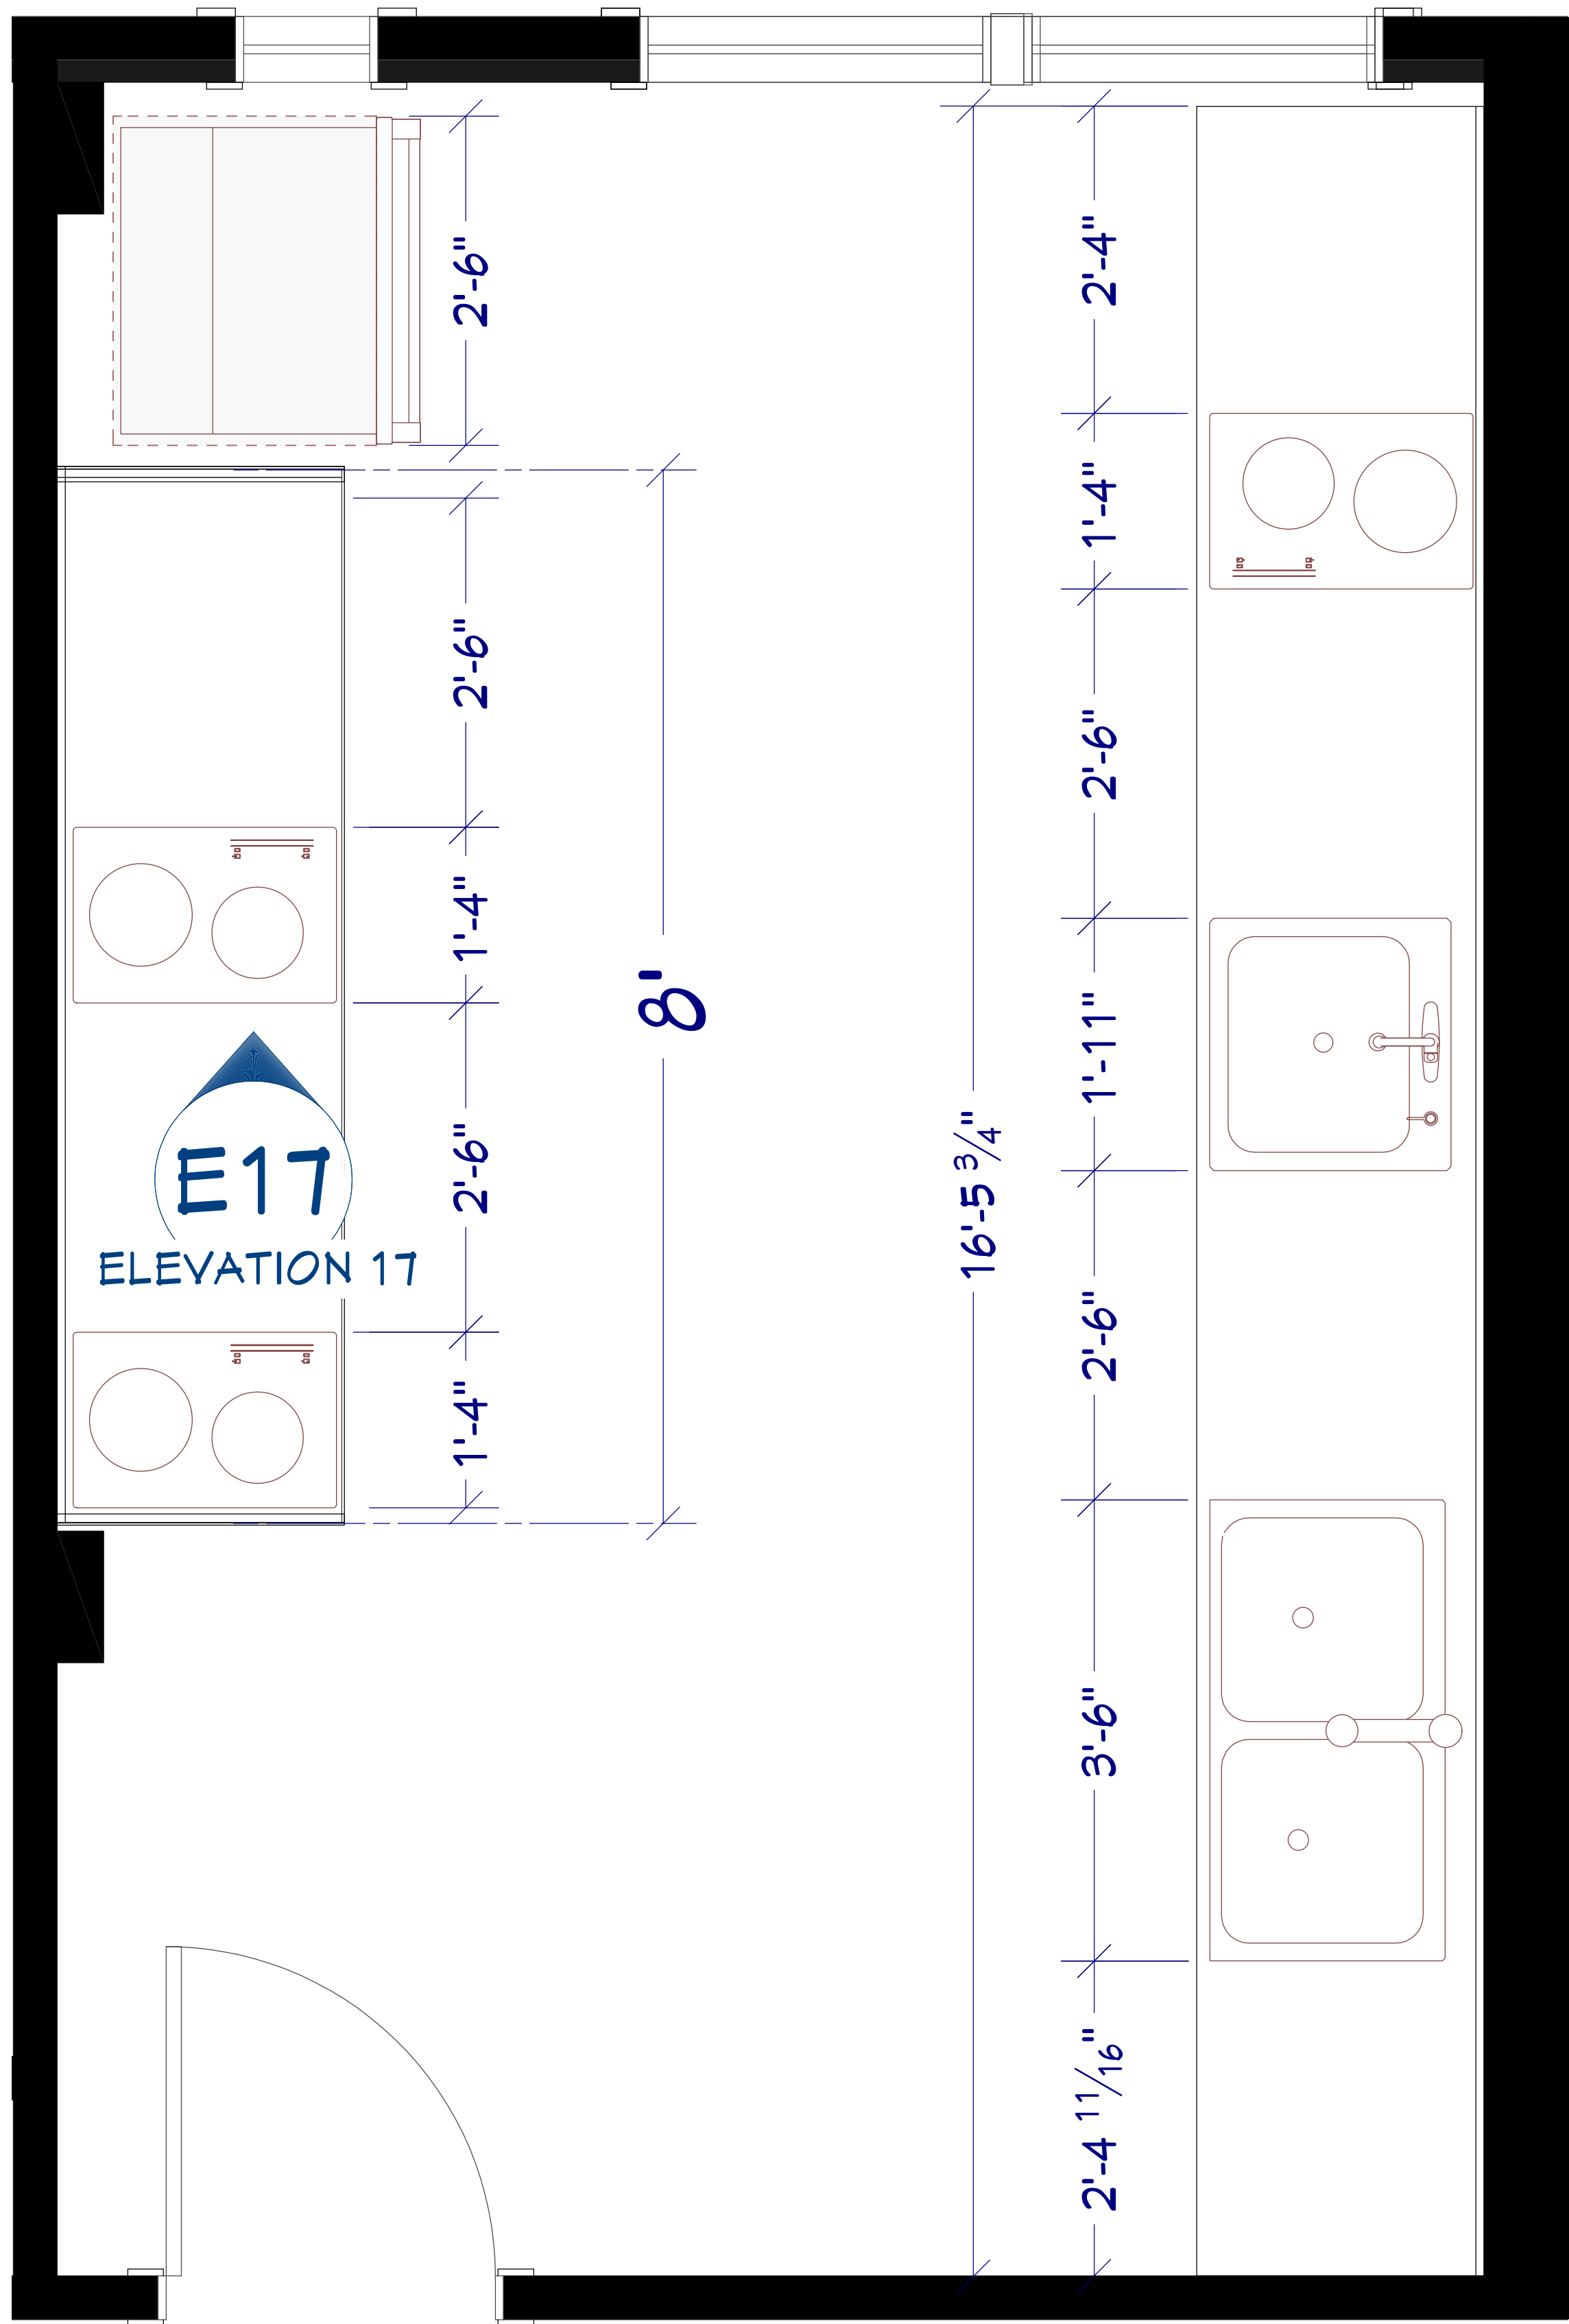

P1	KITCHEN PLAN
A14	

Scale: 1" = 1'



PR.1	COUNTERTOP RENDER
A14	

Scale: N.T.S

KITCHEN COUNTERTOP:
 3/4" PLYWOOD FOR CONSTRUCTION OF COUNTERTOP

CUTOUT FOR SINKS & COOKTOPS

BACKSLASH ALIGNMENT & CUTOUTS FOR SURFACE MOUNT ELECTRICAL LINES

NEW COUNTERTOPS MUST HAVE BACKSPLASH AND OVERHANG VIA STAINLESS STEEL

ALL PLYWOOD TO BE WRAPPED ON THE SIDES AND PER SECTION WITH STAINLESS STEEL

BRACING TO BE CONSTRUCTED AS DIAGRAMMED FOR HORIZONTAL AND LATERAL SUPPORT

CONFIRM ALL CUTOUT DIMENSIONS VIA ONSITE COOKTOPS AND SINKS

REVISION TABLE		DESCRIPTION
NUMBER	DATE	REVISOR

NUMBER	DATE	REVISION	DESCRIPTION

KITCHEN COUNTER DETAILS

LANGLEY HOUSE FULL RENOVATION
GROUND FLOOR

DRAWINGS
PROVIDED BY:

DJNR


DATE:

7/14/2026

SCALE:

SHEET:

A-15

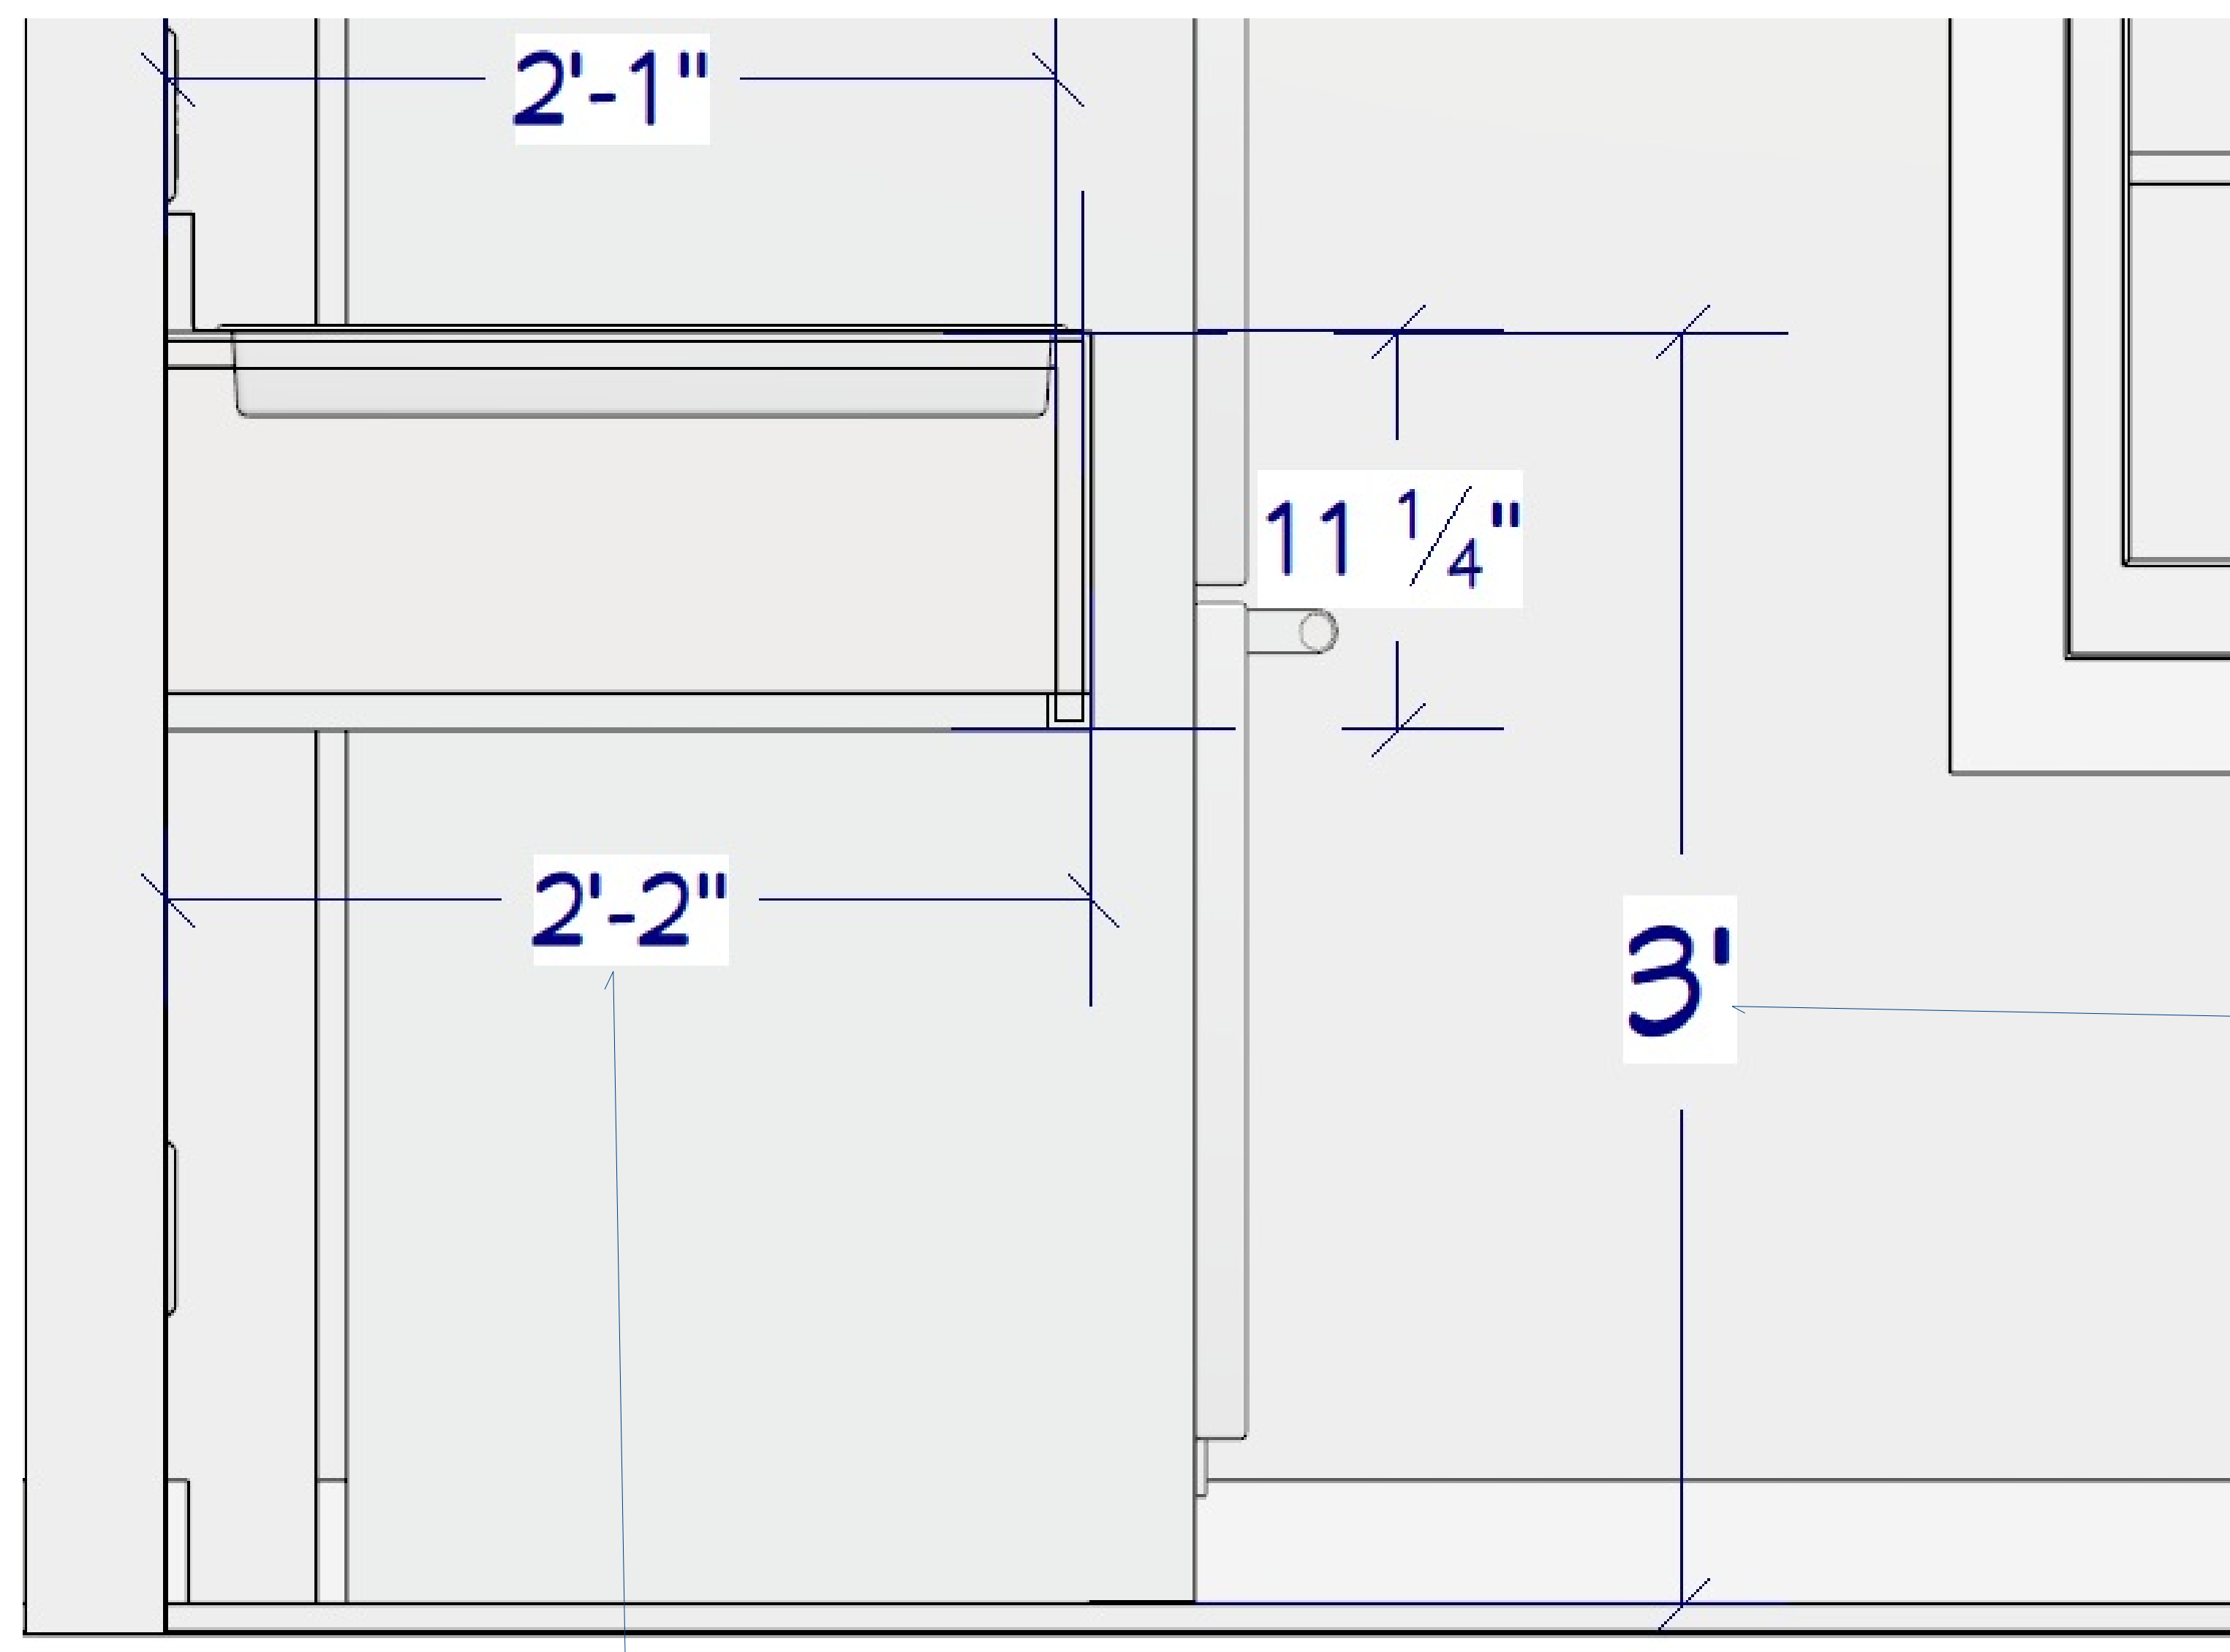

E17
A15 DIMENSIONED COUNTERTOP SECTION
N.T.S.

OVERALL DEPTH VIA FINISHED TILE FROM WALL

Legend:

STAINLESS STEEL WRAPPING ■

3/4 PLYWOOD □

BRACING/BACKET DIAGRAM —

OVERALL HEIGHT
VIA FINISHED TILE
FROM FLOOR




BRACING REFERENCE PHOTO

EX. TILED WALL

COOKTOP TO CUT OUT

INTERNAL PLYWOOD TO CLOSE
IN SIDE OF COUNTERTOPS

INTERNAL STAINLESS STEEL TO
WRAP INTERNAL AND BOTTOM
EDGE OF PLYWOOD

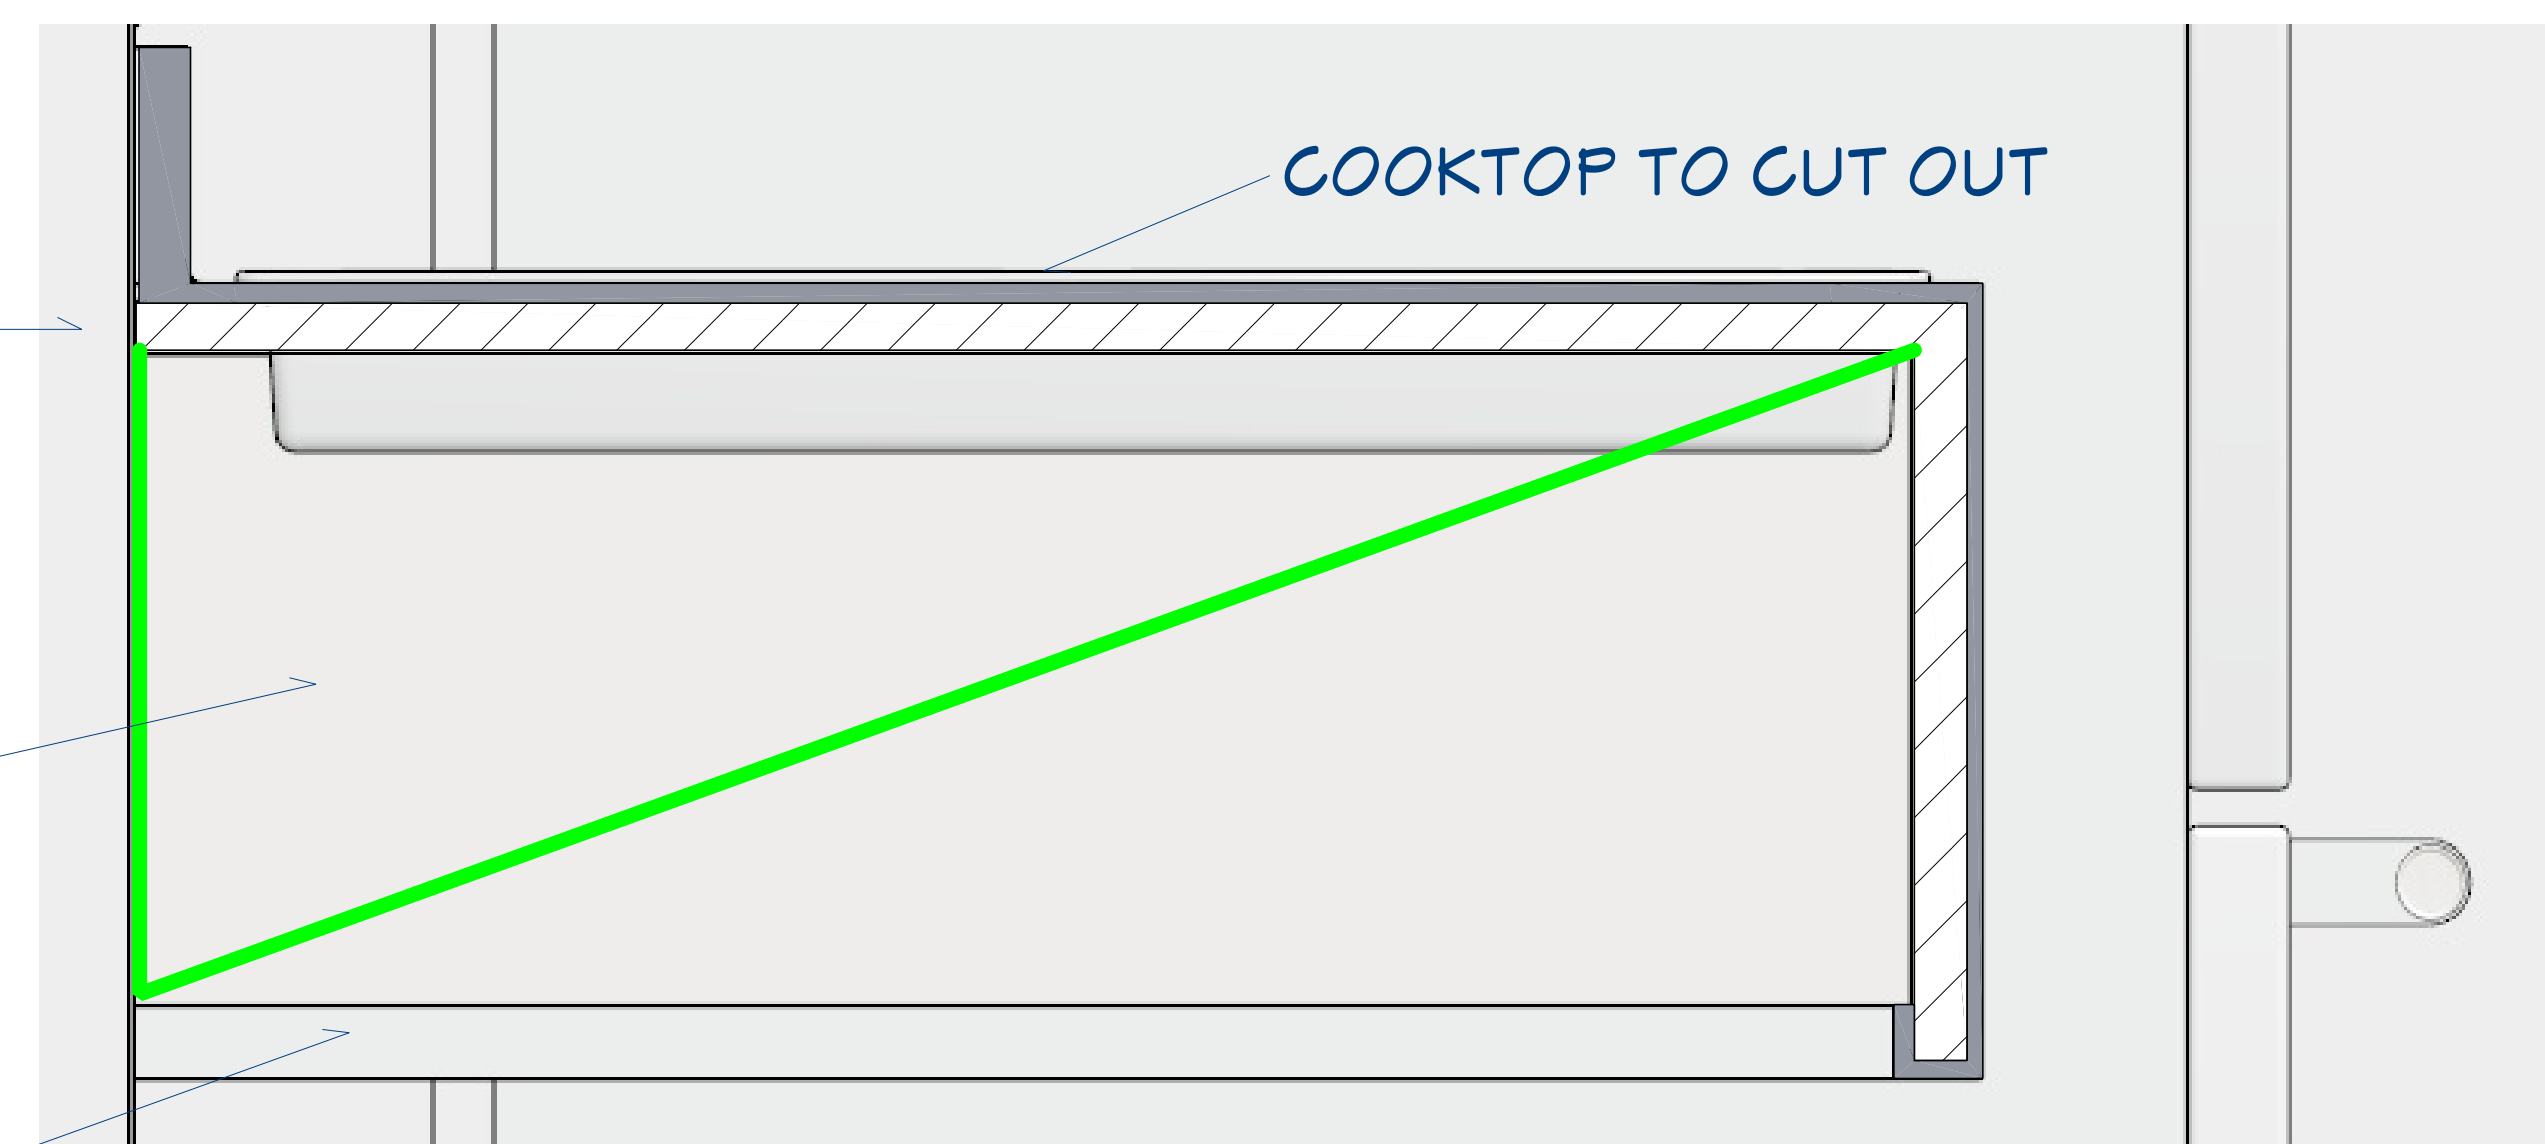

E17
A15 COUNTERTOP SECTION
N.T.S.

COUNTERTOP CONSTRUCTION NOTES:

- ALL PLYWOOD EDGES TO BE ROUNDED
- SITE SURFACE MOUNT CUTOUTS MUST BE COORDINATED ON SITE
- BRACING VIA DIAGRAM TO BE IN INTERVALS ALONG THE WIDTH AROUND EACH DROP IN APPLIANCE AND AT THE ENDS OF THE COUNTERTOP
- ALL COUNTERTOPS TO BE FASTENED INTO THE EX TILE AND WALL
- STAINLESS STEEL WRAPPING MEASURED AS 1/4" BUT IS 2MM